


METRIC

ALL DIMENSIONS SHOWN ARE IN METRES AND/OR MILLIMETRES UNLESS OTHERWISE NOTED.

NOTES:


1. PROVIDE PLYWOOD BACKBOARD AS PER SPECIFICATIONS FOR COMM. ROOM WALL.
2. PROVIDE UNISTRUT CHANNELS AS NOTED ON DRAWING ELECTRICAL BUILDING GENERAL POWER LAYOUT.
3. REFER TO ELECTRIFICATION STANDARDS AND SPECIFICATIONS FOR GROUNDING AND BONDING, EMI/EMF WITHSTAND REQUIREMENTS, CABLING REQUIREMENTS

NOTE:
THIS DRAWING IS PROVIDED FOR INSTRUCTIONAL DESIGN PURPOSES ONLY BASED ON METROLINX GO TRANSIT DESIGN GUIDELINES AND REQUIREMENTS. THE CONSULTANT SHALL VERIFY FOR LOCAL CODE COMPLIANCE, EXISTING SITE CONDITIONS AND INTER DISCIPLINARY DRAWING COORDINATION. ALL DIMENSIONS AND SPECIFICATIONS SHOULD BE VERIFIED BY CONSULTANT AND/OR CONTRACTOR BEFORE ACTUAL CONSTRUCTION BEGINS.

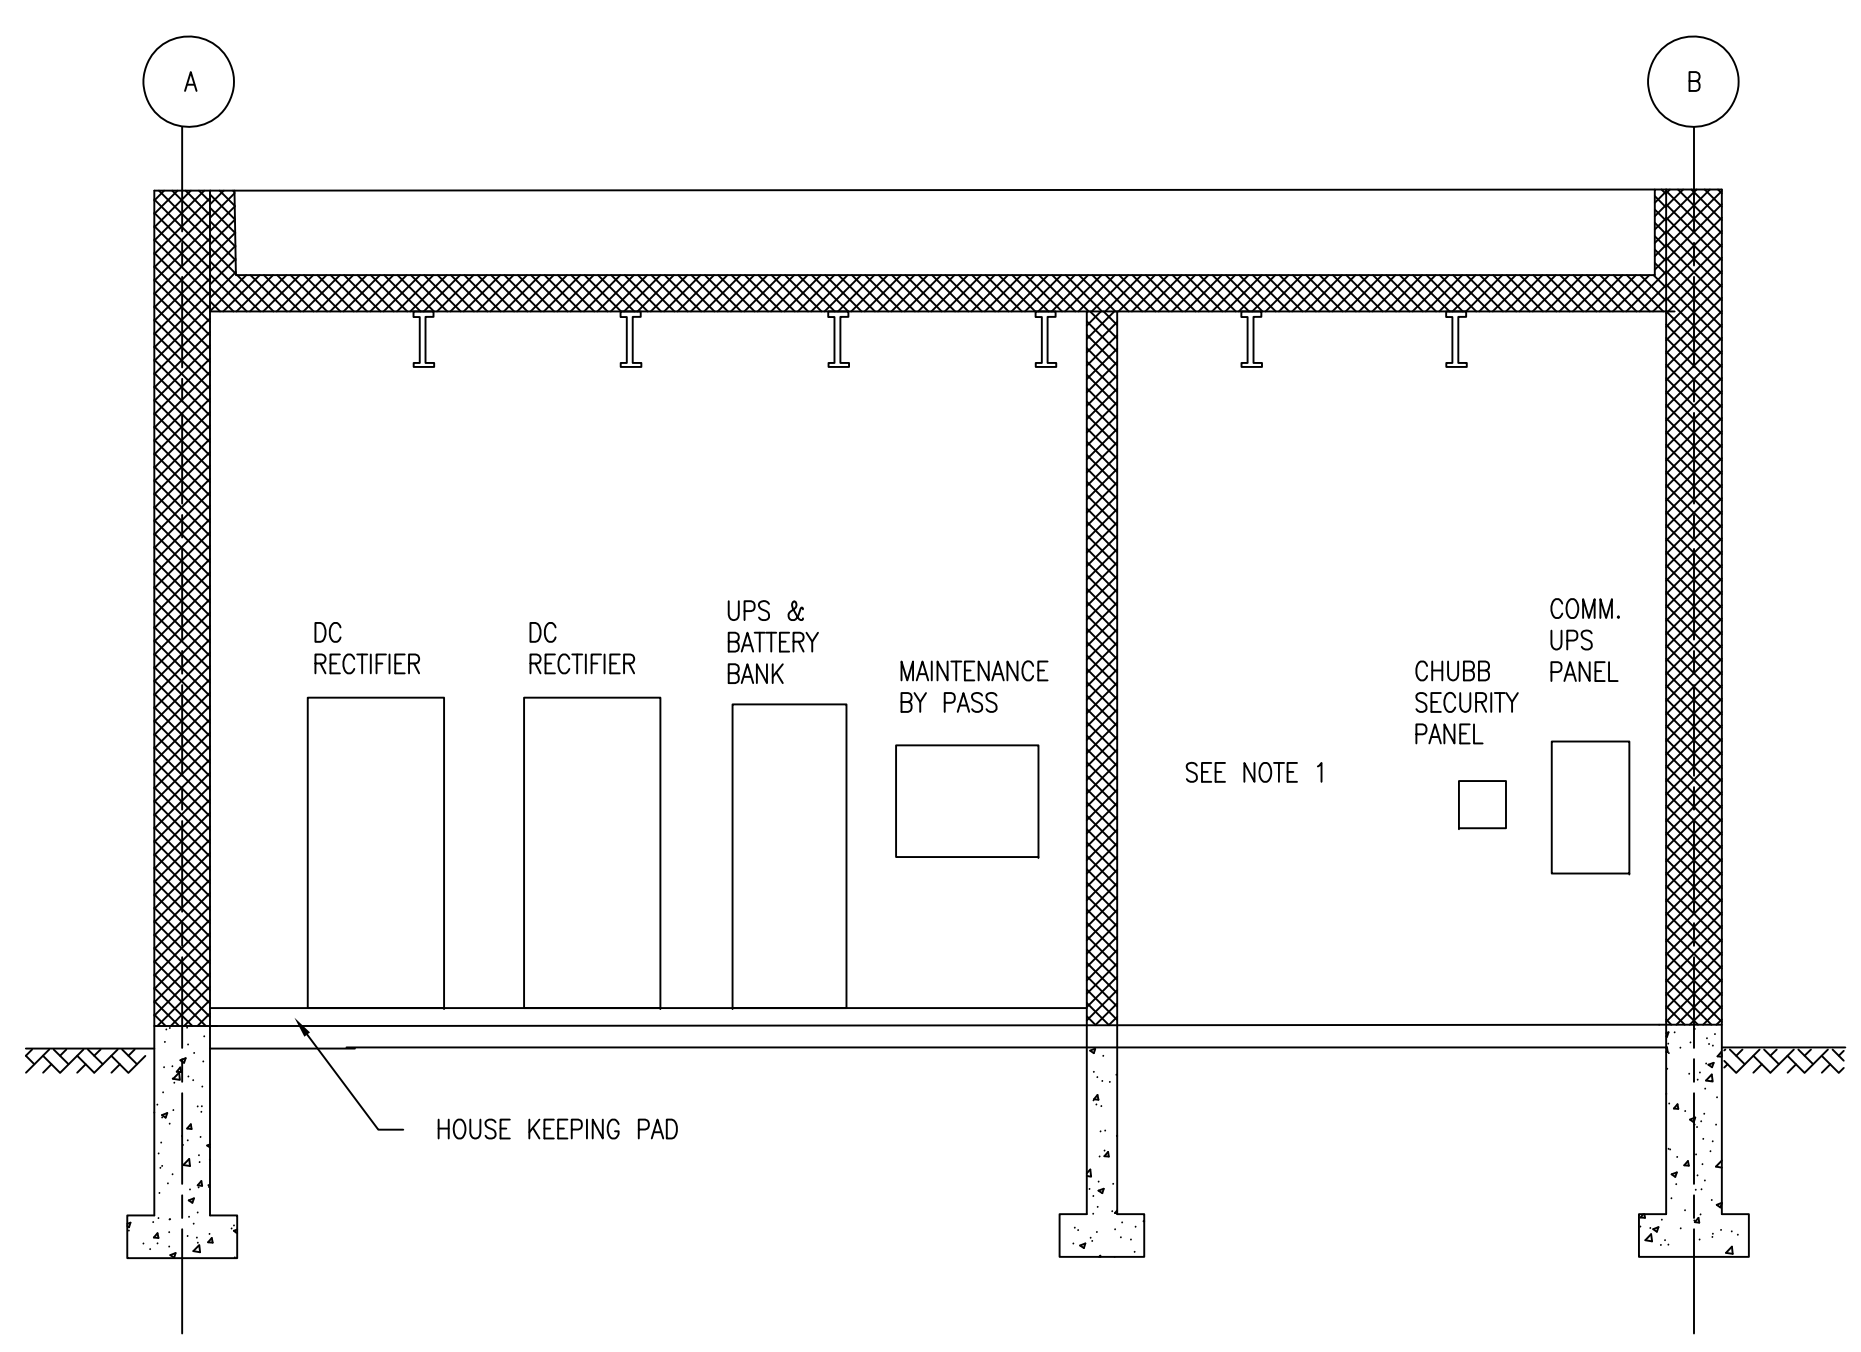


UPS/RECTIFIER ROOM & COMMUNICATION ROOM
NORTH ELEVATION

1
WSP-104 NTS

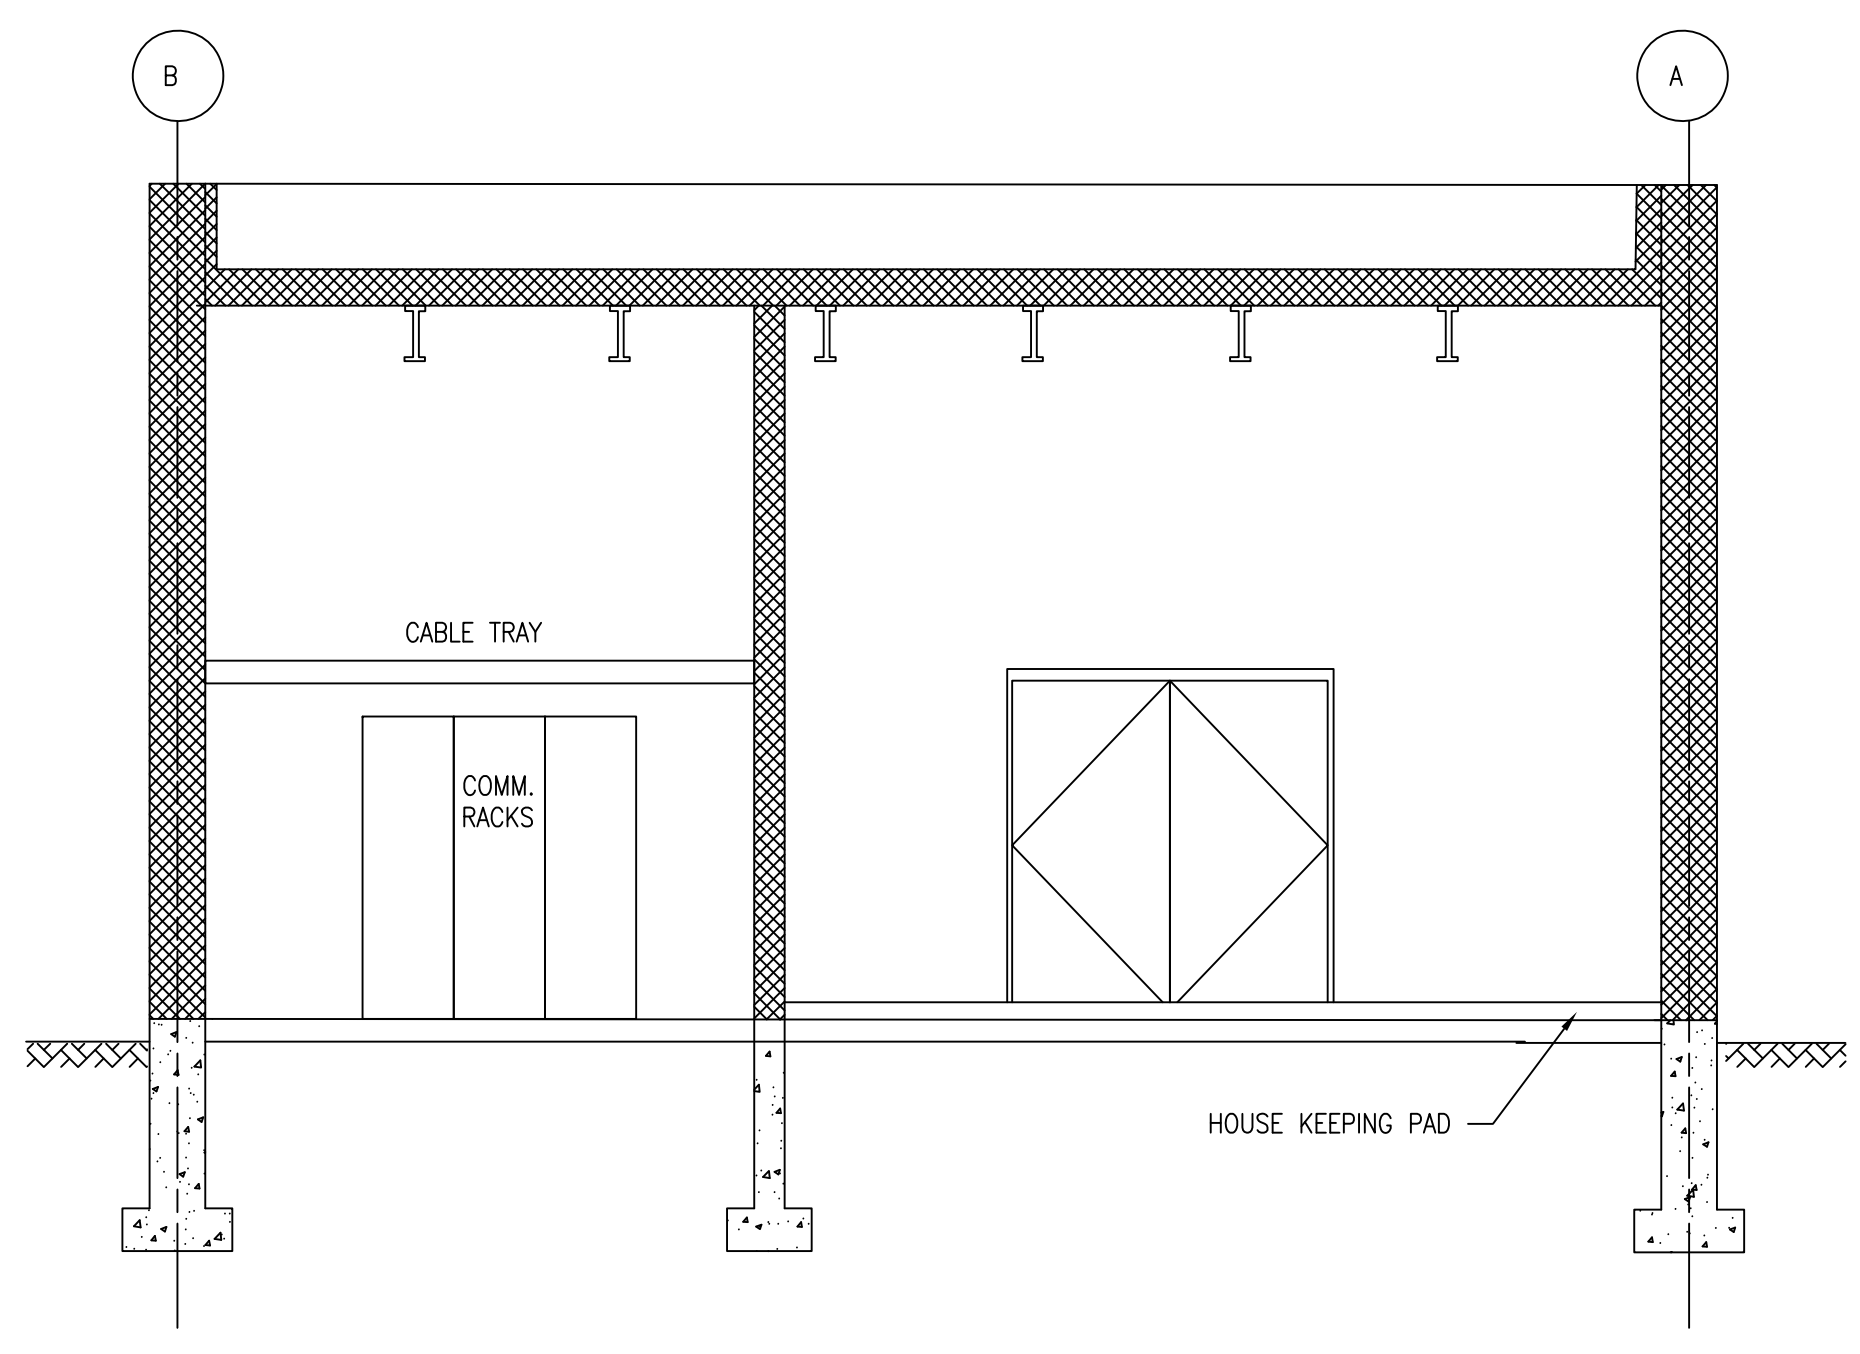

UPS/RECTIFIER ROOM & COMMUNICATION ROOM
SOUTH ELEVATION

3
WSP-104 NTS

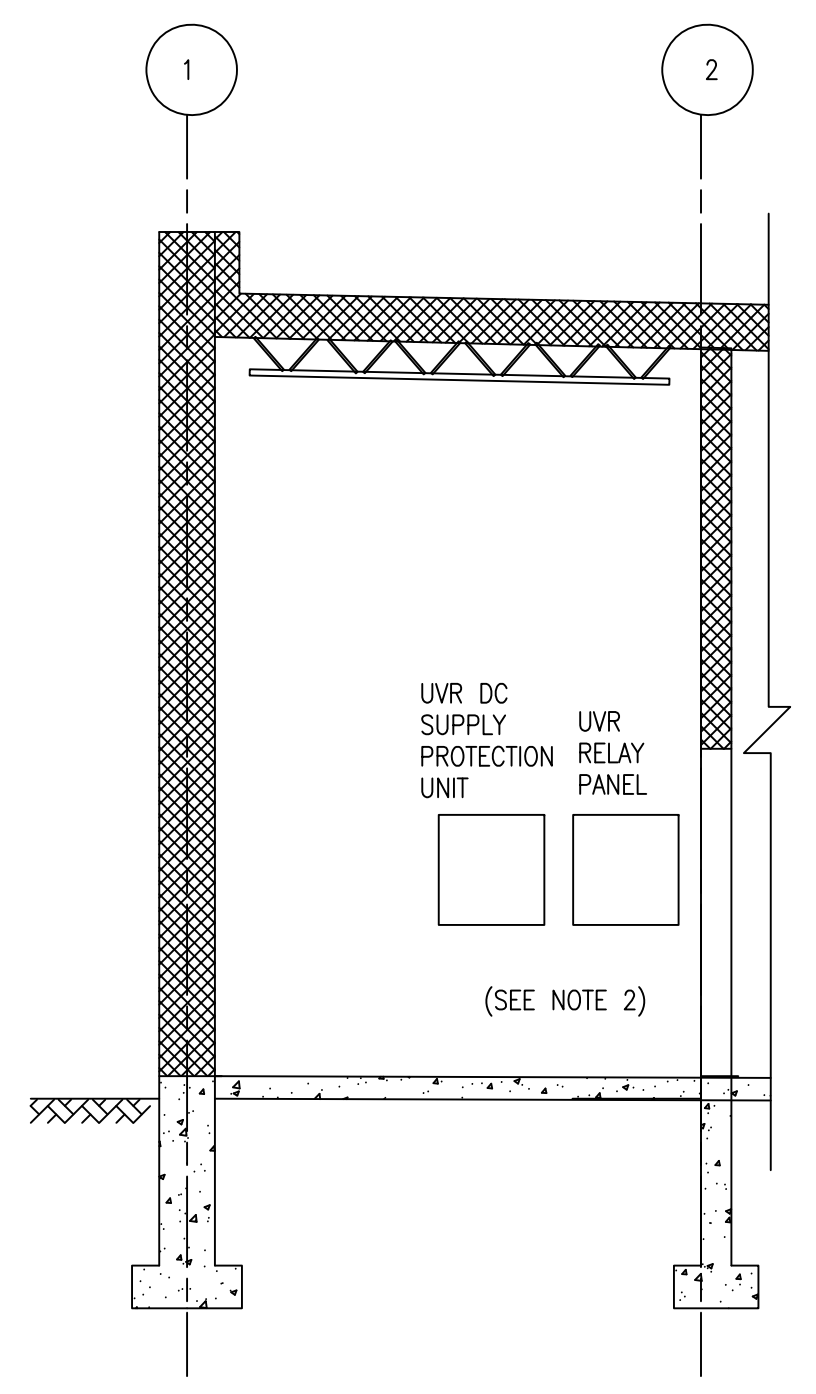


UPS ROOM EAST ELEVATION

2
WSP-104 NTS

GO TRANSIT PROJECT NO. XXXXX

REFERENCE DRAWINGS	ISSUE	REVISIONS	DRAWN BY:	DESIGNED BY:
			CHECKED BY:	APPROVED BY:
			SCALE: NTS	FULL SIZE ONLY
DWG NO.	TITLE	REV. DATE	ISSUED FOR	REV. DATE

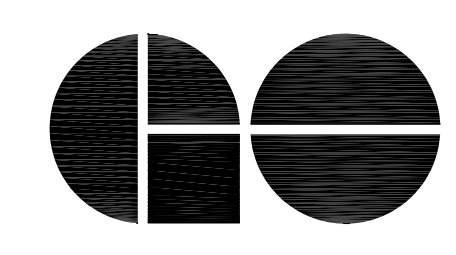

A Division of Metrolinx

XXXXXX
WAYSIDE POWER
SUBSTATION BUILDING
ELEVATIONS 2 OF 2

CONTRACT NO. XXXXXXXXXX	DWG. NO. WSP-047	REV. 1	SHEET XX
----------------------------	---------------------	-----------	-------------